





 


ROOF PLAN

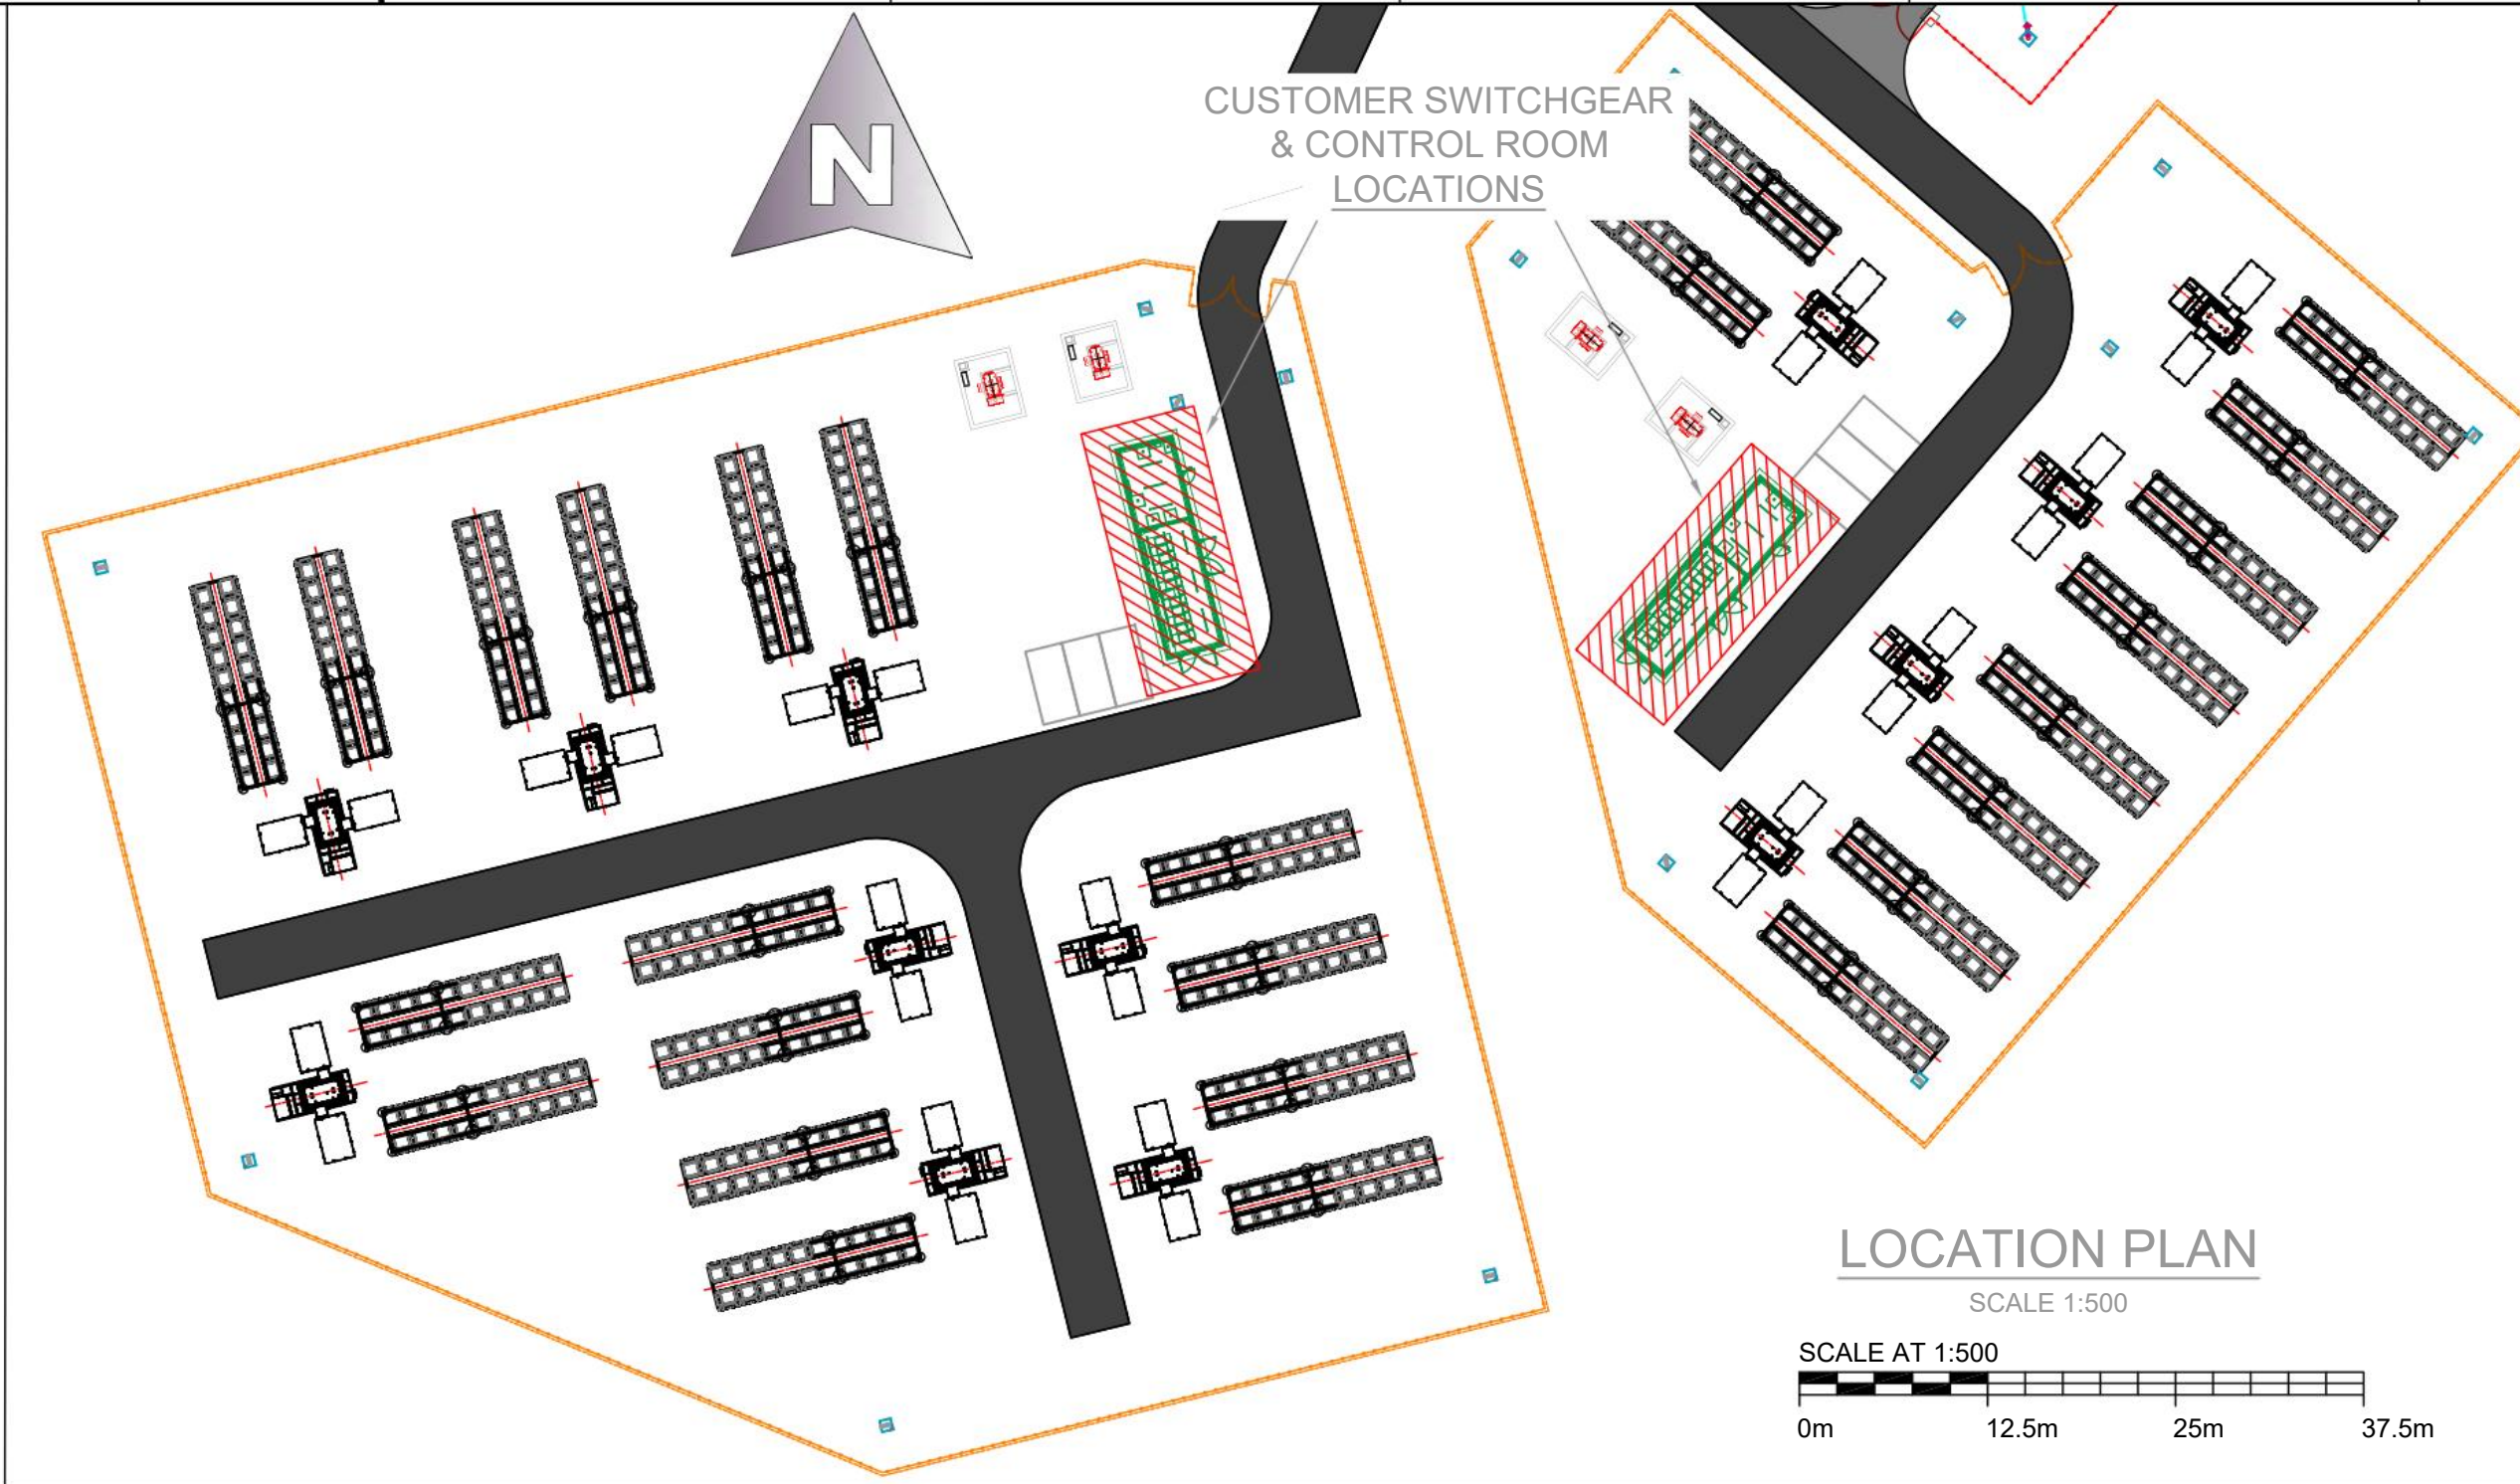

LOCATION PLAN

SCALE 1:500

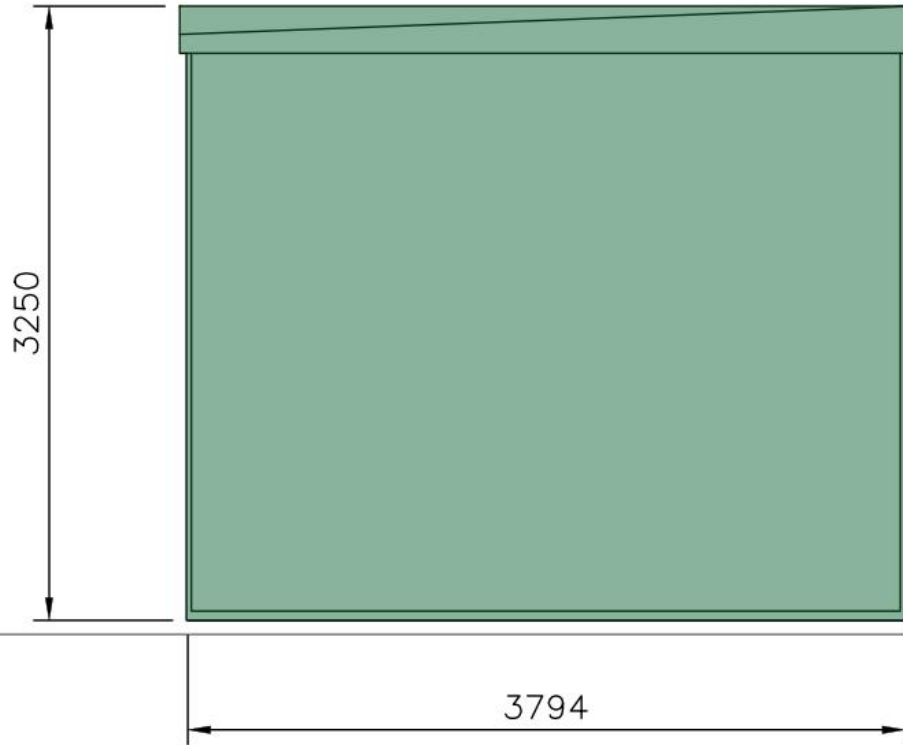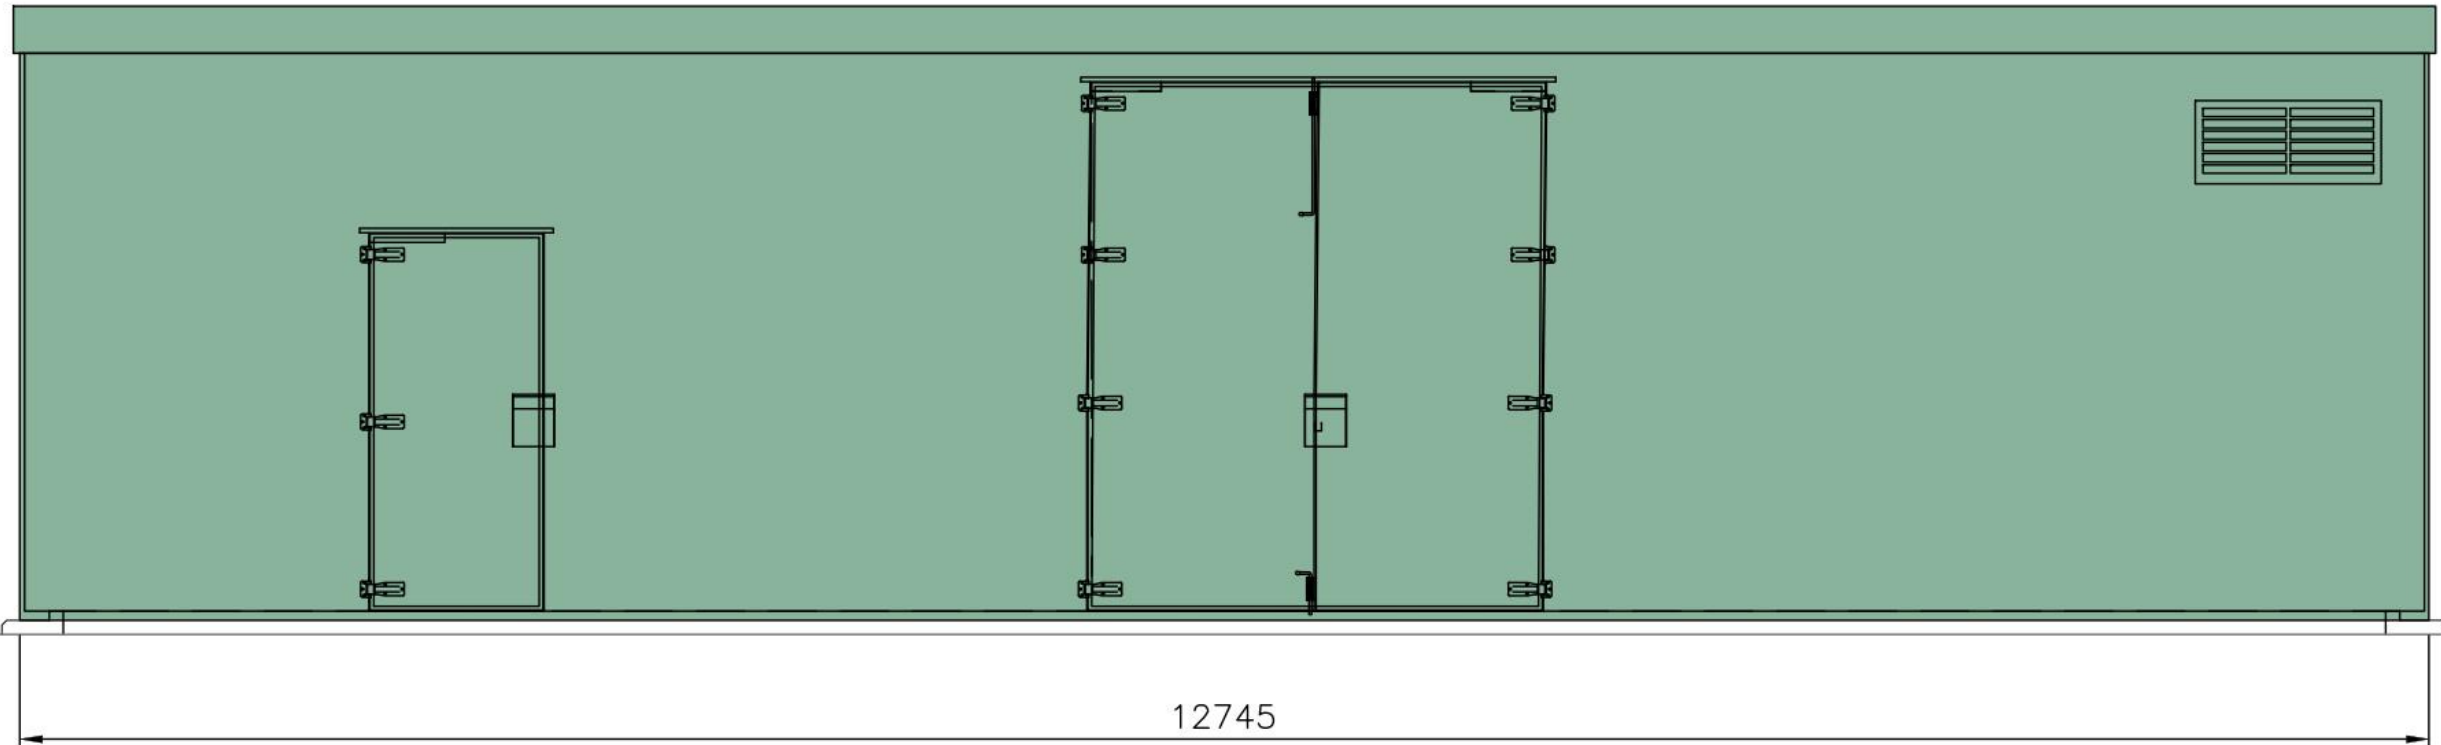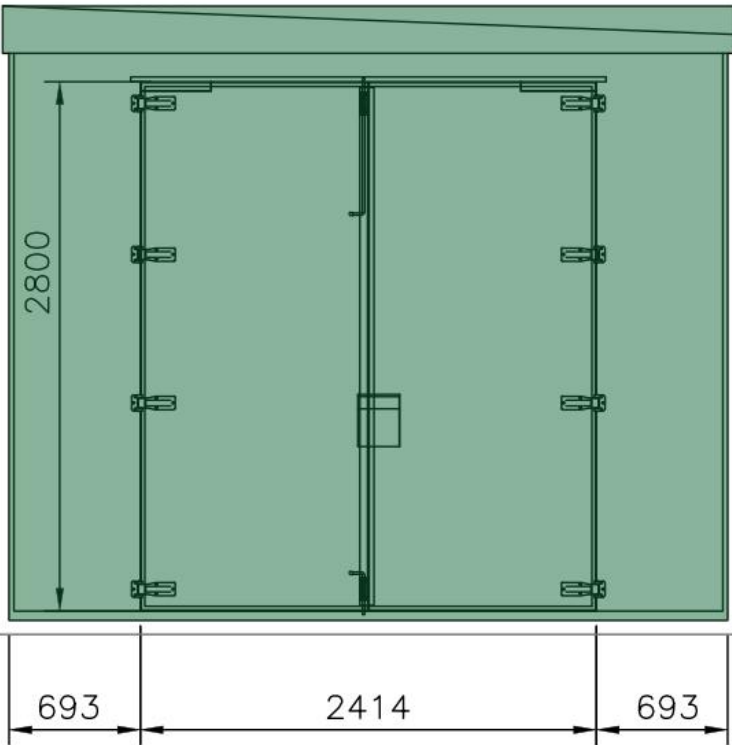

CUSTOMER SWITCHROOM AND CONTROL BUILDING

11 12

This document is protected by copyright and design rights. Any unauthorised reproduction would be an infringement and may lead to appropriate legal action.  
© Ethical Power Connections Copyright  
Do not scale from this drawing

NOTES

1. THIS DRAWING TO BE READ IN CONJUNCTION WITH ALL RELEVANT ENGINEERS AND SPECIALISTS DRAWINGS & SPECIFICATIONS.
2. ANY DISCREPANCIES BETWEEN THIS DRAWING AND ANY OTHER TO BE REPORTED TO THE ENGINEER IMMEDIATELY.
3. ALL WORKS TO COMPLY WITH THE MOST CURRENT BRITISH STANDARDS.
4. ALL DIMENSIONS IN MILLIMETERS UNLESS STATED OTHERWISE. NO DIMENSIONS ARE TO BE SCALED OFF THE DRAWING. USE FIGURED DIMENSIONS ONLY.
5. ALL DIMENSIONS TO BE  $\pm 3\text{mm}$  UNLESS SPECIFIED OTHERWISE.

0.4	KEY PLAN AMENDED TO SHOW PENN 2			
	JW	KF	JA	16/01/2023
0.3	LOCATION PLAN AMENDED. ROOF PLAN ADDED.			
	JW	KF	JA	02/11/2022
0.2	AMENDED FOLLOWING COMMENTS FROM PLANNING ISSUE			
	TG	LC	AF	27/08/2021
0.1	FIRST ISSUE			
	AW	LC	AF	07/07/2021
REV	Description			
	DESIGNED	CHECKED	APPROVED	DATE



Unit 9, Dunchideock Barton, Dunchideock,  
Exeter, Devon, EX2 9UA  
(t) 01726 218618  
www.ethical-power.com

Project Title: PENN  
Description: CUSTOMER SWITCHGEAR & CONTROL ROOM ELEVATIONS  
Location co-ord: OS Grid ref.: 386100 , 295300  
Site address: BLACKPIT LANE,  
LOWER PENN,  
WV4 4YA

Drg No: EPC-0339-C-E-LA-CCR  
Scale: 1:40@A1  
Job No: 0339  
Drawn by: TG  
Checked by: LC  
Date: 21/07/21

